



ELECTRICAL LEGEND

□	CEILING OUTLET - FLUORESCENT
○	CEILING OUTLET - INCANDESCENT
S	SINGLE POLE SWITCH BRYANT CAT. NO. 4501 WITH BRYANT "UNILINE" PLATES
S ₃	THREE WAY SWITCH 4503
S ₄	FOUR WAY SWITCH 4504
⊖wo	1/2" RECEPTACLE OUTLET BRYANT CAT. NO. 5242 WITH BRYANT "UNILINE" PLATES "W" INDICATES WEATHER-PROOF RECEPTACLE SWITCH CAT. NO. 5-60
⌈	WALLS IN CONCEALED CONDUIT WALL MOUNTED
⌋	WALL MOUNTED OUTLET
⌌	WALL MOUNTED SWITCH
⌍	WALL MOUNTED RECEPTACLE
⌎	WALL MOUNTED SWITCH
⌏	WALL MOUNTED RECEPTACLE
⌐	WALL MOUNTED SWITCH


INTERCOM SYSTEM

Ⓜ	INDICATES A CALL SWITCH - BRYANT NO. 7-D-15 FLUSH MOUNTED 1/2" HIGH
Ⓞ	SPEAKER - BRYANT NO. 9955-S CAT. NO. 975-145 1/2" X 1/2" X 1/2" A COVER
Ⓡ	TRUMPET - BRYANT NO. 8-35
ⓇPR	INDICATES TO PULL TO CLOSE CIRCUIT

PROGRAM SYSTEM

Ⓞ	CLOCK - EDWARDS NO. 972-12"
Ⓡ	BELL - EDWARDS NO. 340-4" INTERPHONE NO. 340-6 1/2" X 1/2" X 1/2" FOR WITH CHD EXT. EXTENSOR

Handwritten note: ALL SWITCHES TO BE INSTALLED WITH 1/2" X 1/2" X 1/2" A COVER. THE WALLS AT THESE LOCATIONS SHALL BE REINFORCED WITH...

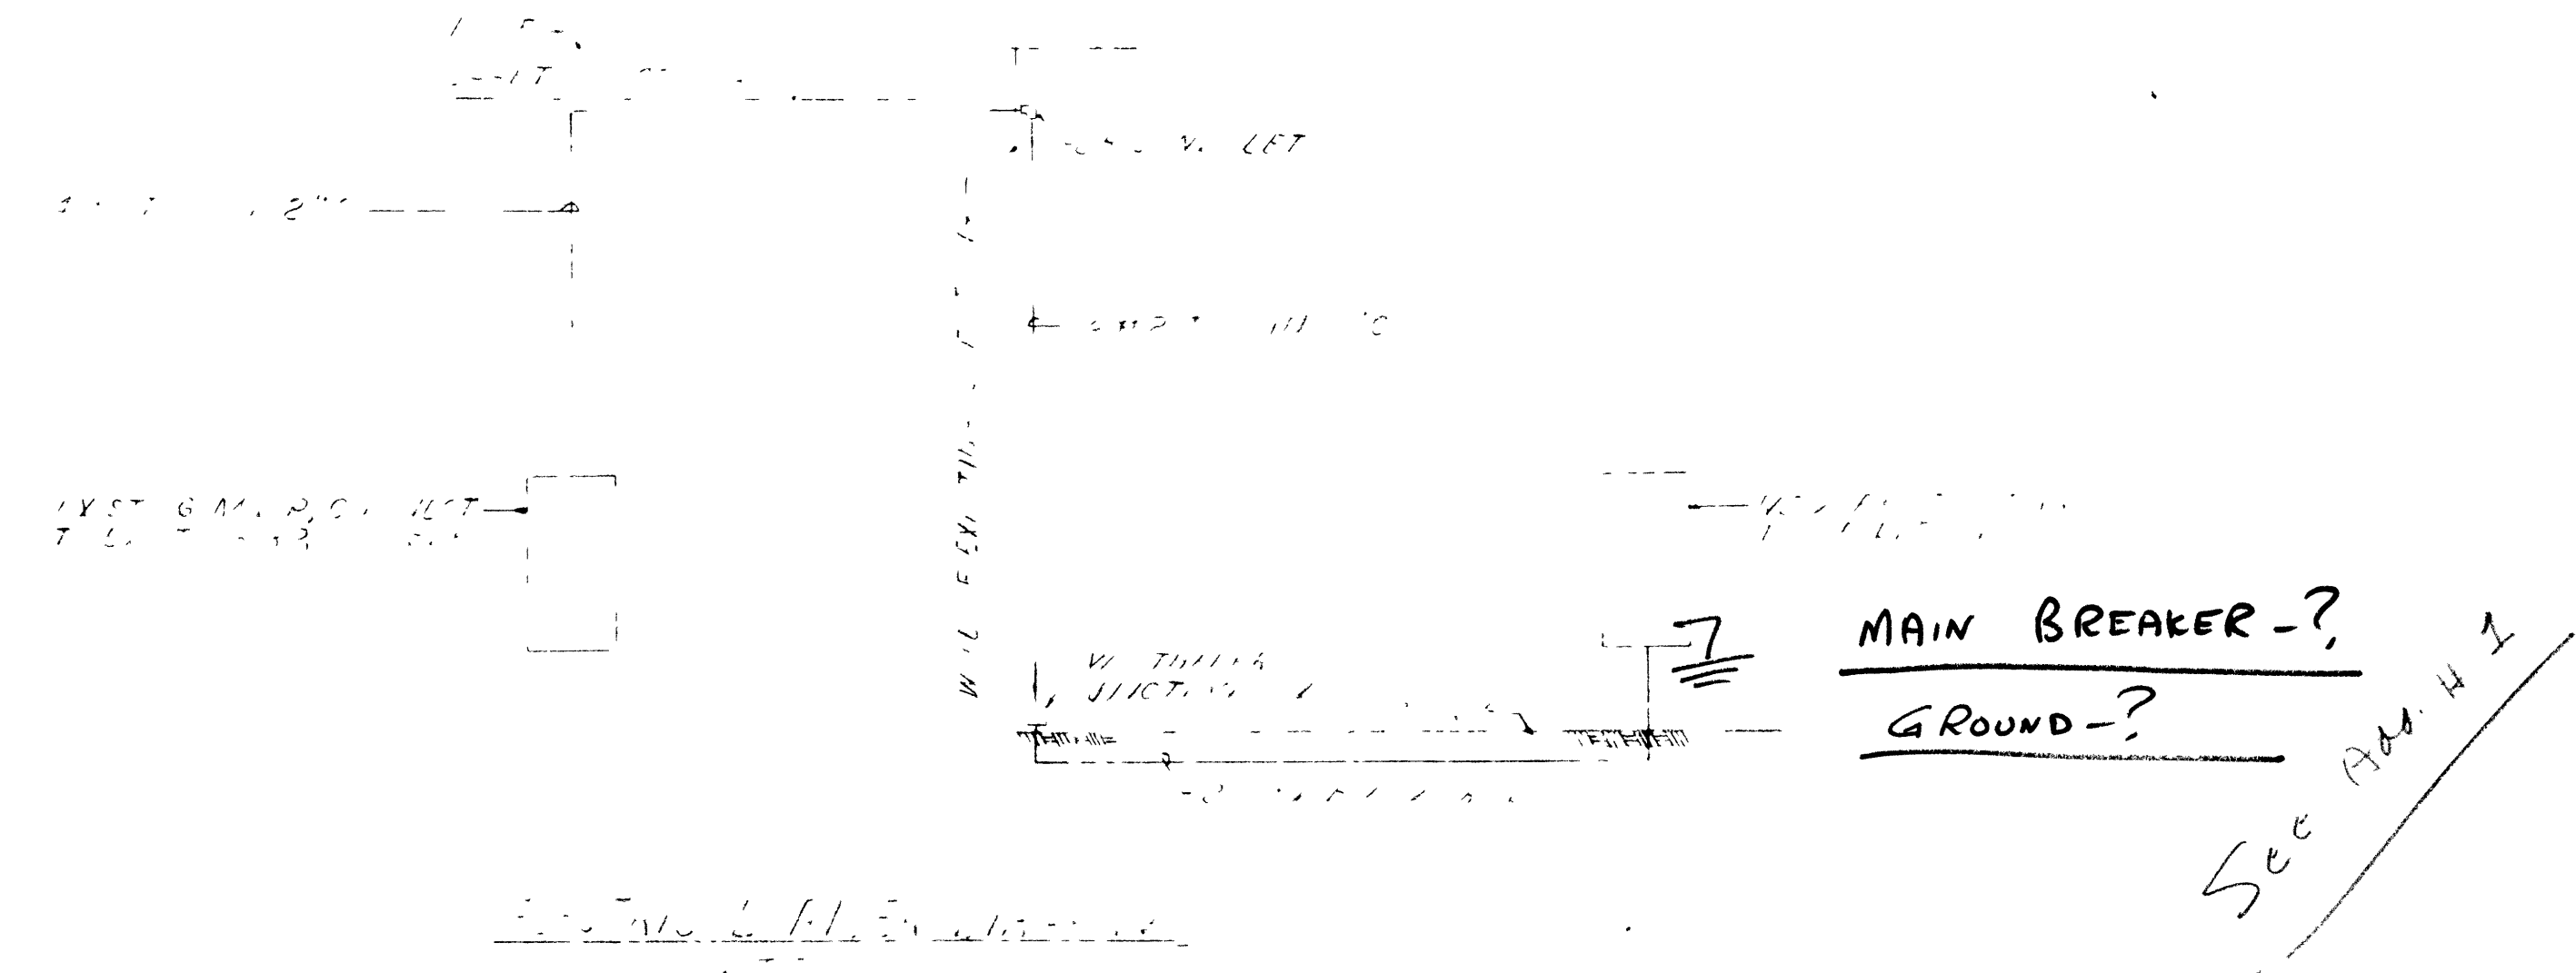

RECEIVED

JUN 26 1968

200 1420 DIVISION OF SCHOOL PLANNING

A CLASSROOM ADDITION TO		
ANDREWS HIGH SCHOOL		
ANDREWS, NORTH CAROLINA		
DRAWN BY	SITE PLAN & DETAILS	DATE 6-11-68
JAMES L. PADGETT, AIA, ARCHITECT		SHEET NO E-1
SUITE 405 NORTHWESTERN BANK BUILDING ASHEVILLE, NORTH CAROLINA 28807		OF 2

