


Sheet number
E-10
0123

RECEIVED
C.W.C.
DRAWN
L/11/75
DATE

EDUCATIONAL UNIT
for the Onslow County
Board of Education
Onslow County, N.C.

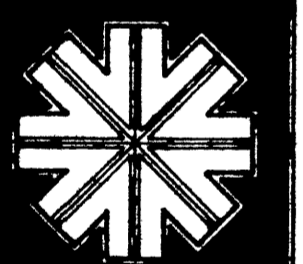


ERIC TOWNSON, A.I.A.
architect - Murphy, N.C.



REECE, NOLAND & MCELRAITH
CONSULTING ENGINEERS
P.O. BOX 540/MAYNESVILLE, NORTH CAROLINA 28786
MAYNESVILLE 7041 456 9851
ASHEVILLE 7041 253 3280

ANDREWS JR. HIGH
DIVISION OF
SCHOOL PLANNING
JUL 30 1975
200 1420

1/8" = 0'
LIGHTING FLOOR PLAN

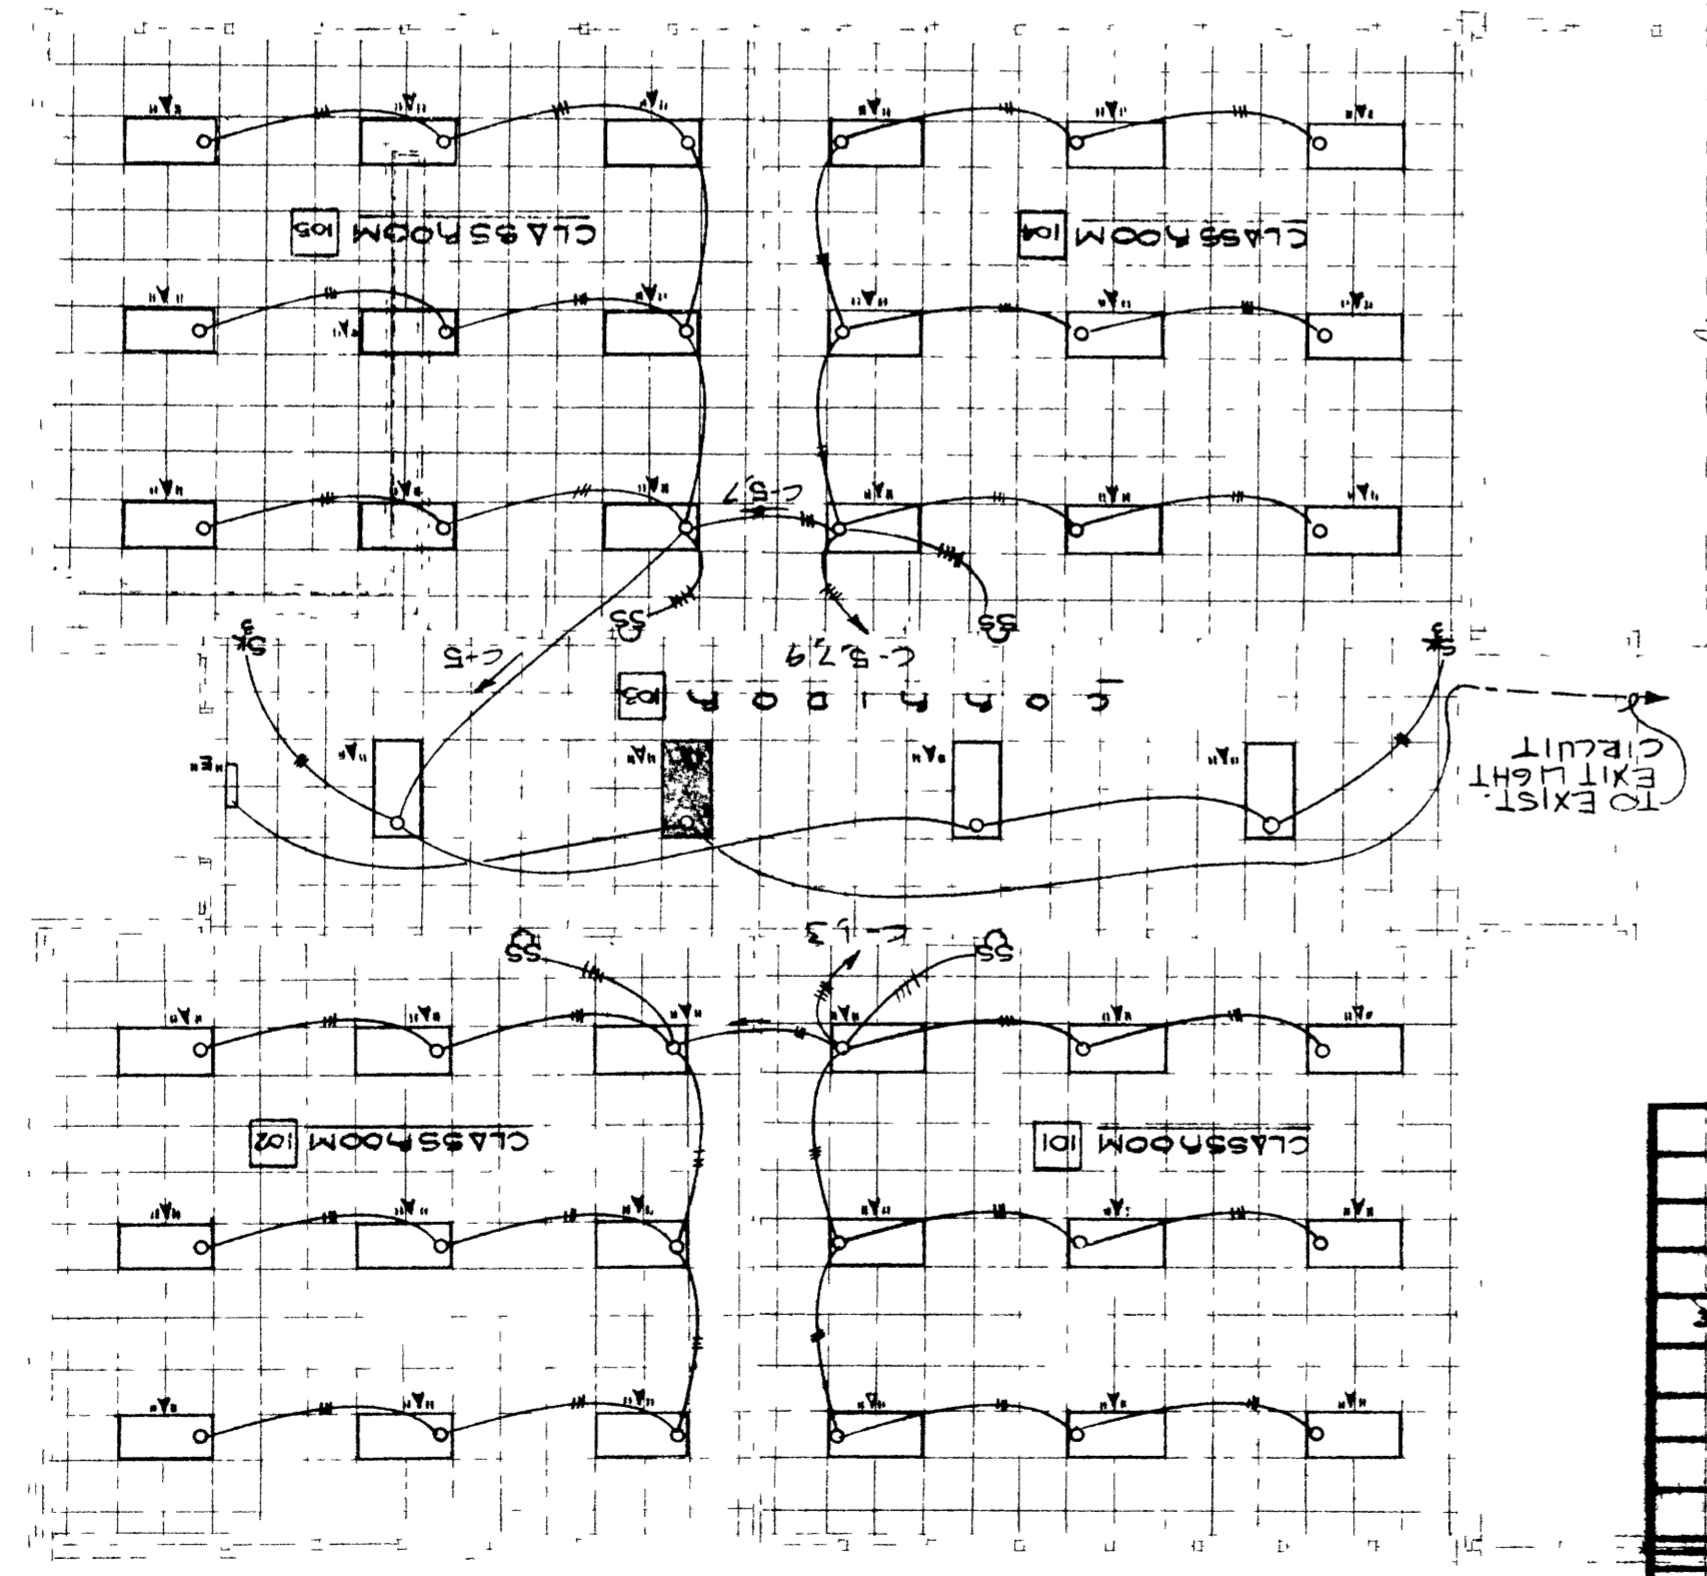

NOTE: CLASSROOM LIGHTS TO BE SWITCHED FOR HALF OR FULL ILLUMINATION

3730
 57
 53
 52
 51
 0

DESCRIPTION/Remarks: Square ft. NOB-18-LT. 120/208, 3%, 4 wire 100 amp M.D.L. flush mounted
Wires: 4- #12 Or.
Conduit: 1 1/2" C

DESCRIPTION	Cond.	Wire	Load	Breaker	Panel	Panel	Panel
101 C.R. 101	3 #12	720W	3 #12	1P-20	2	101	101
102 C.R. 102	3 #12	720W	3 #12	1P-20	4	102	102
103 C.R. 103	3 #12	720W	3 #12	1P-20	6	103	103
104 C.R. 104	1/2	720W	1/2	1P-20	7	104	104
105 C.R. 105	1/2	720W	1/2	1P-20	8	105	105
7 #12 1/2"	1P-20	1500W	1/2"	1P-20	9	105	105
SPACE ONLY					10		
11 C 12	1P-20				11		
14 A 14	1P-20				14		
15 B 16	1P-20				15		
18 C 18	1P-20				18		

Panel # C " SCHEDULE
Connected Load: 10.2 KW
Wires: 4- #12 Or.
Conduit: 1 1/2" C

DESCRIPTION/Remarks: Square ft. NOB-18-LT. 120/208, 3%, 4 wire 100 amp M.D.L. flush mounted
Wires: 4- #12 Or.
Conduit: 1 1/2" C