

6
SHEET
M-3


REVISIONS
APPROVAL DATE 4/2/12
JOB NO. AMS-5
DRAWN BY UAKE
SYSTEMS
FLOOR WARMING
GYMNASIUM
SCHOOL
CHEROK
COUNTY
SCHOOL

ANDREWS
MIDDLE SCHOOL


McKNIGHT-SMITH
WARD · GRIFFIN
ENGINEERS, INCORPORATED
P.O. Box 240826 · 4223 South Boulevard

ARCHITECTURE


4 PIPING SCHEMATIC
M-3 NTS

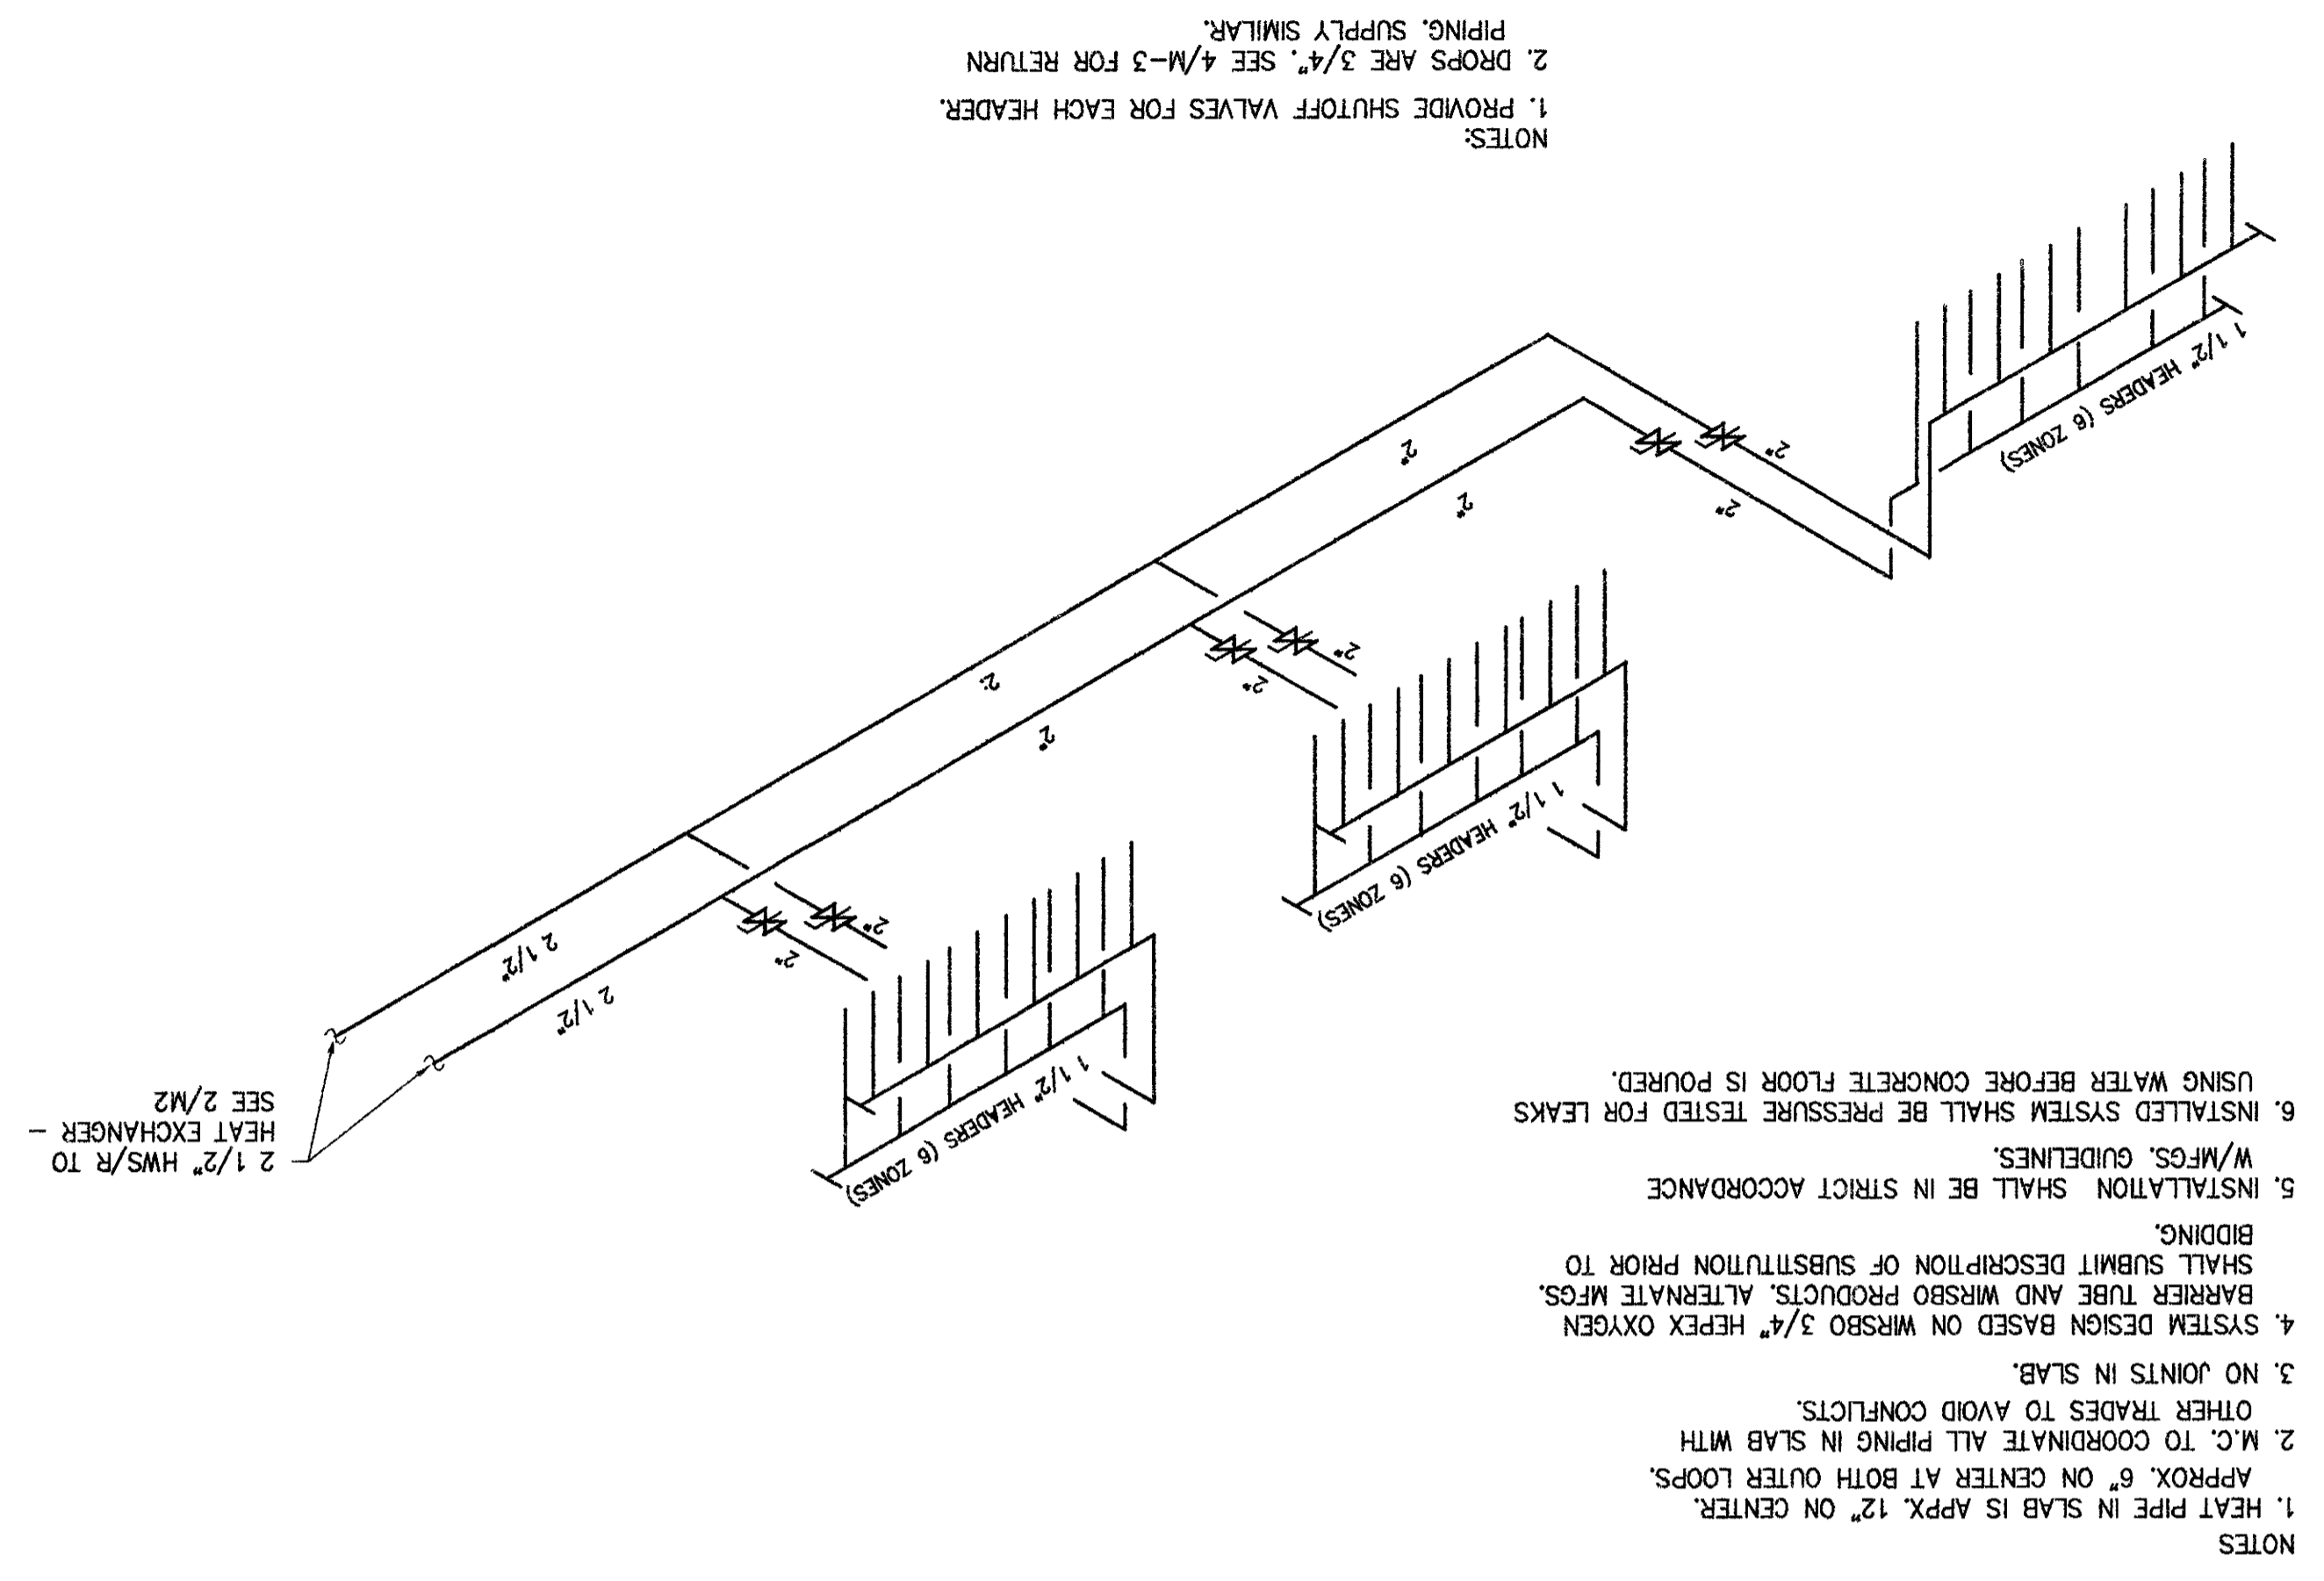


5 SECTION @ WOOD FLOOR
M-3 NTS

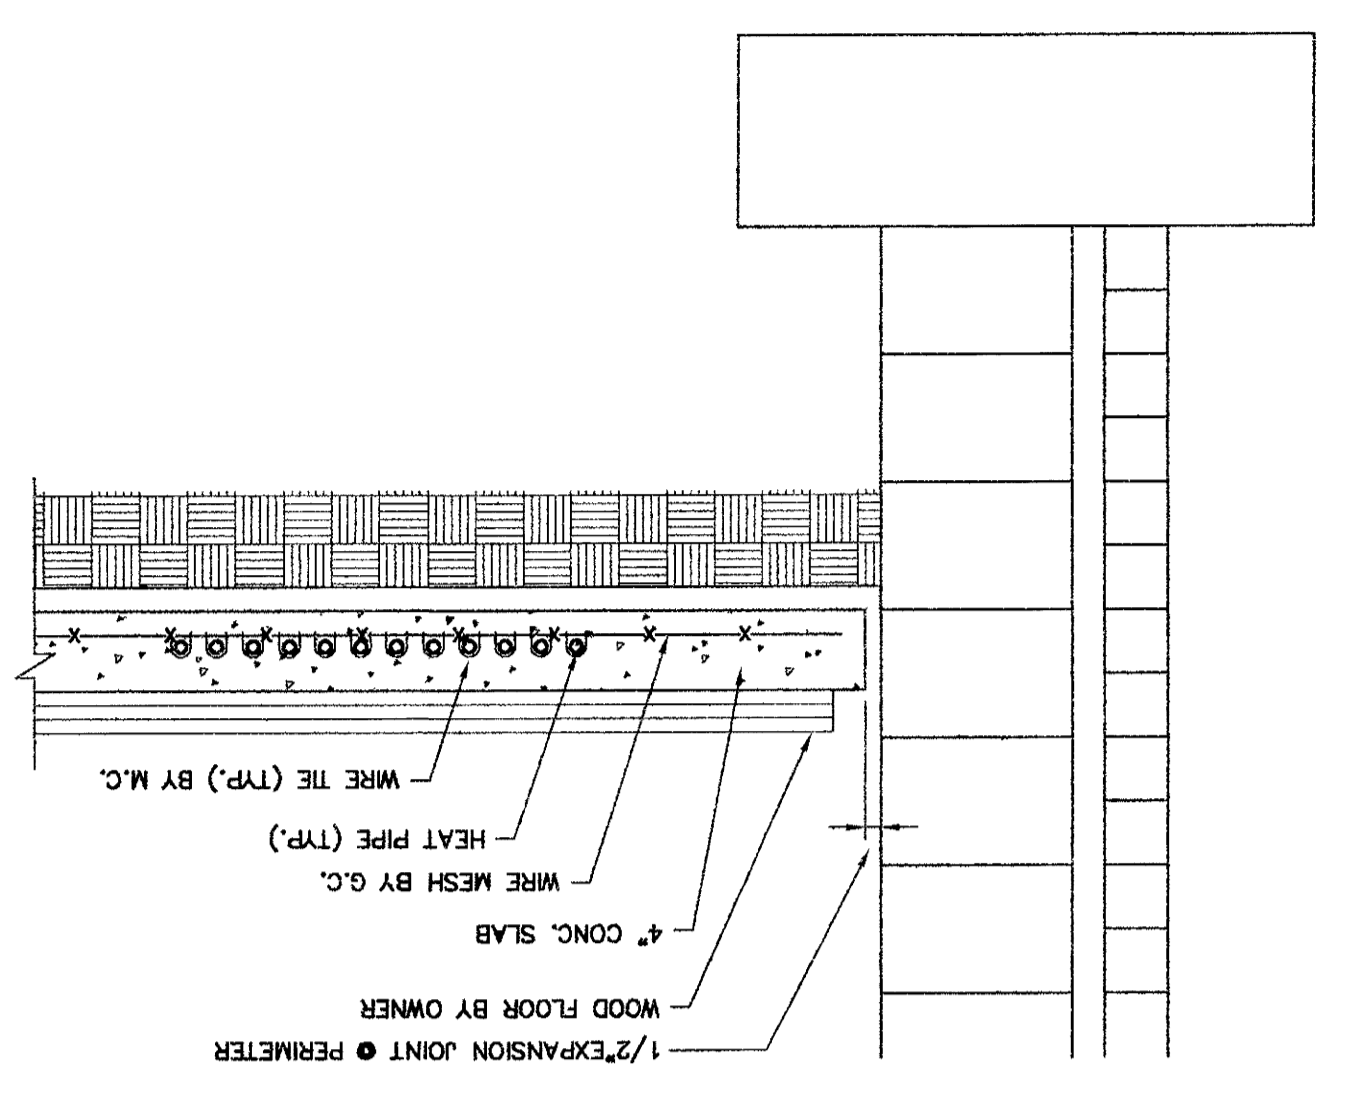


1 GYMNASIUM BELOW FLOOR HEAT PIPING
M-3 1/8"=1'-0"

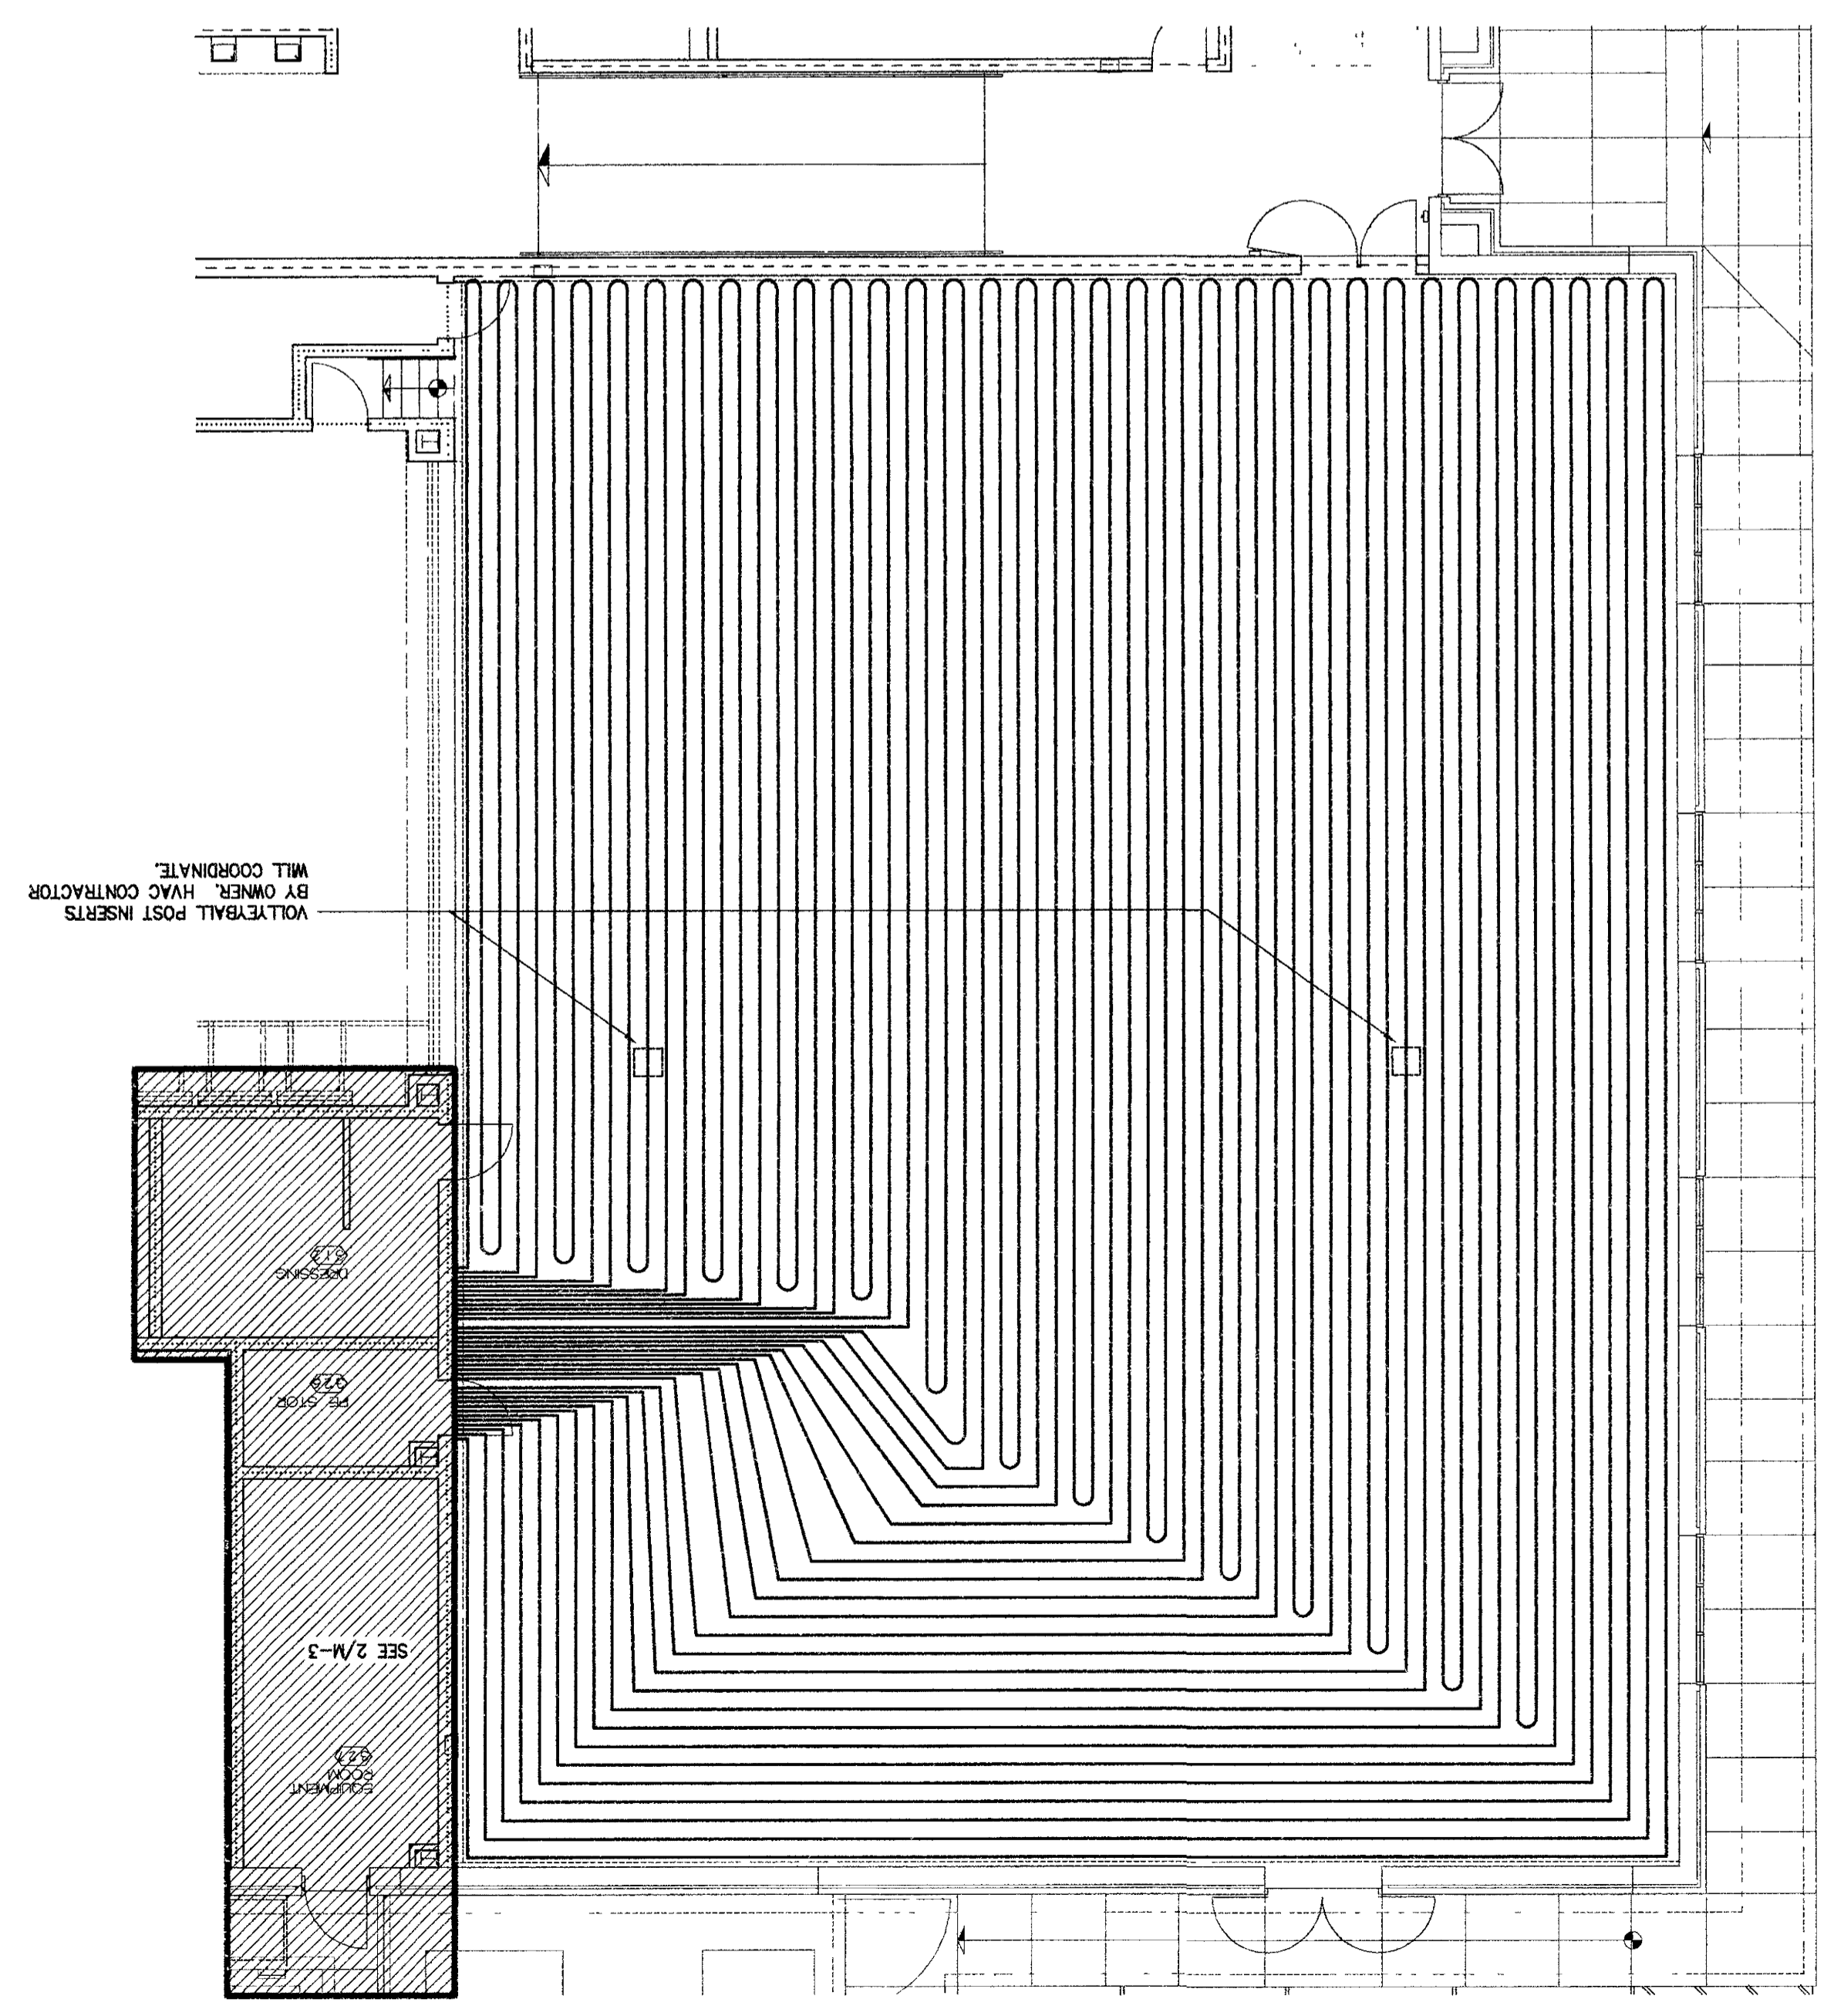

2 PARTIAL FLOOR PLAN
M-3 1/4"=1'-0"

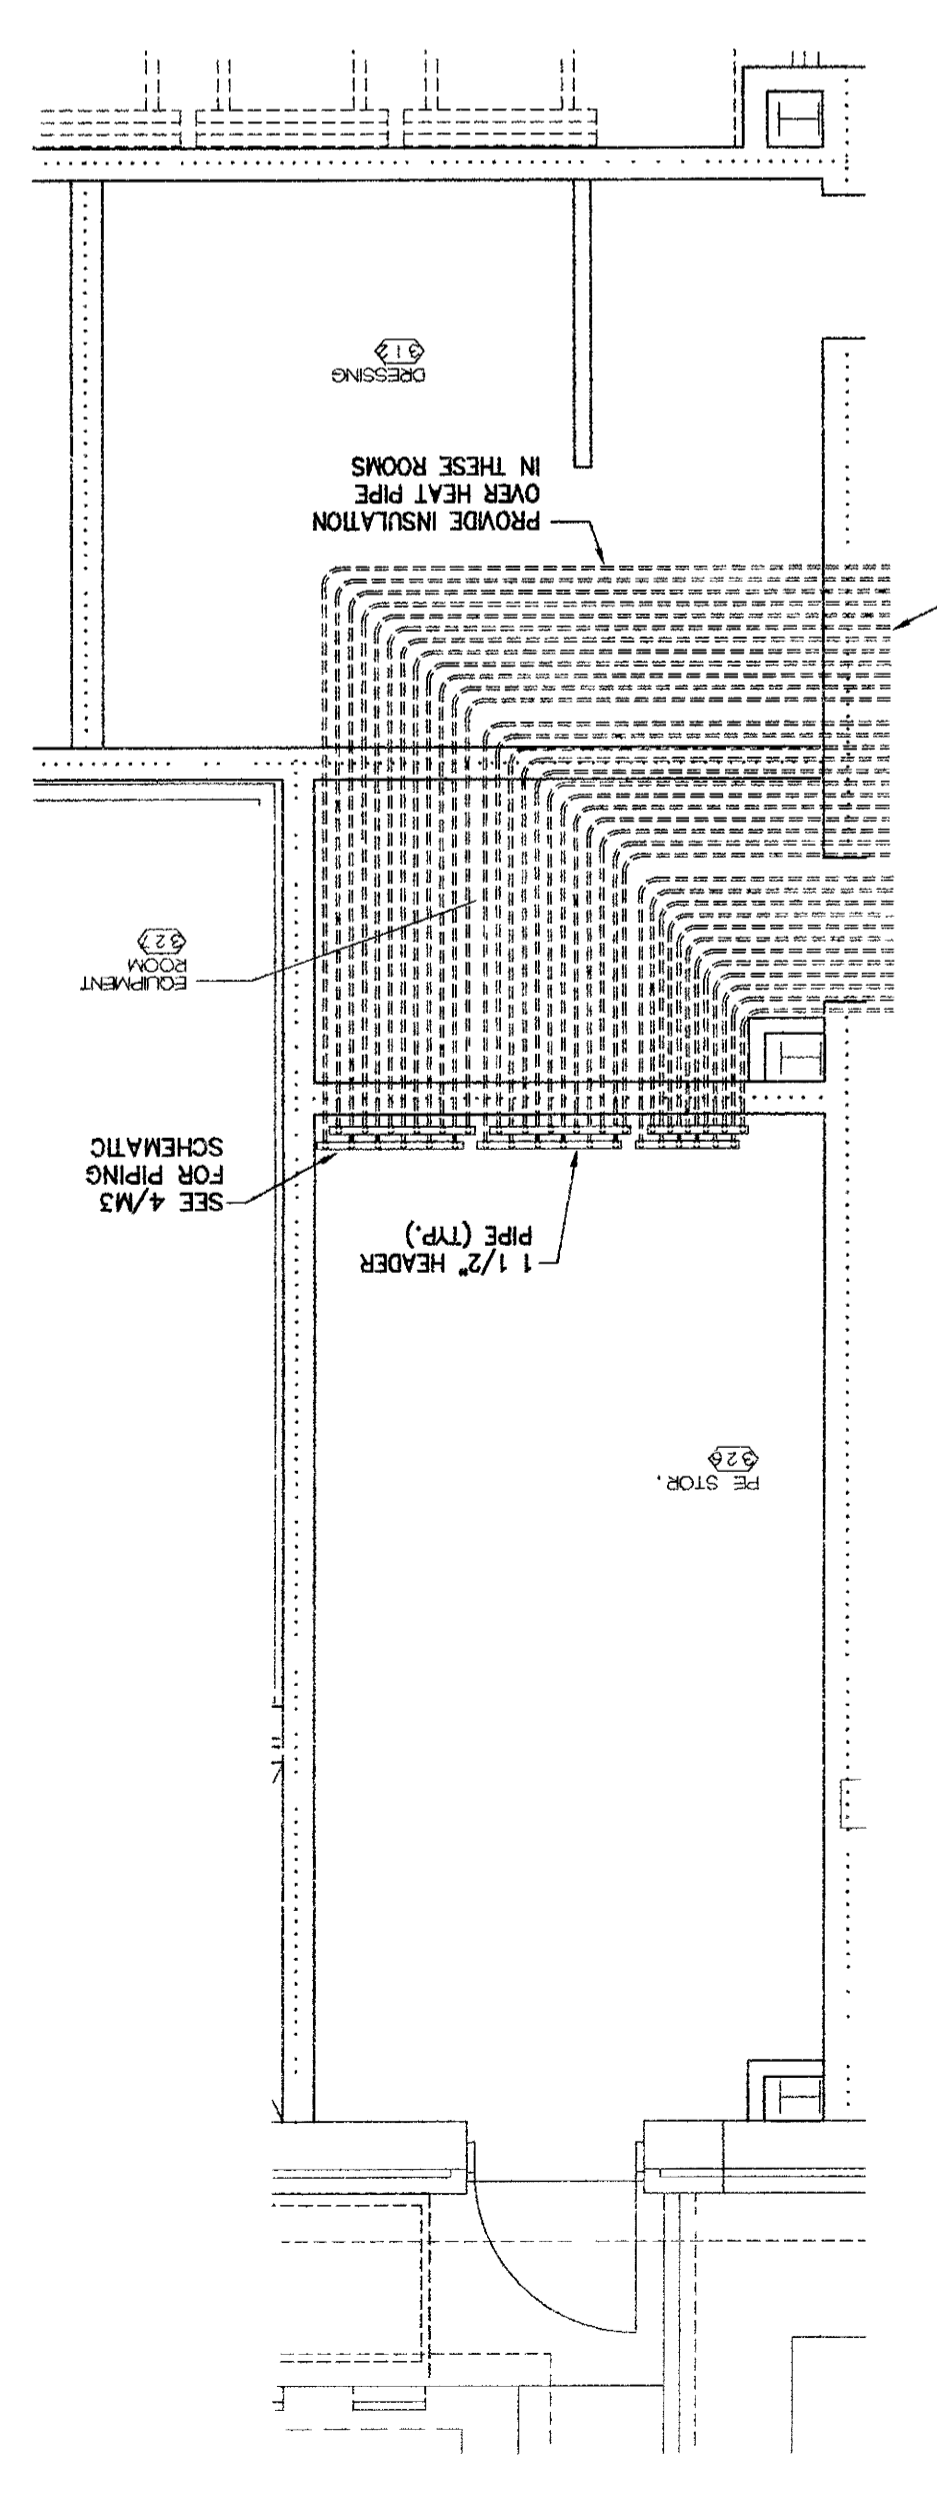

6 HEAT EXCHANGER DETAIL (WATER TO WATER)
M-3 NTS

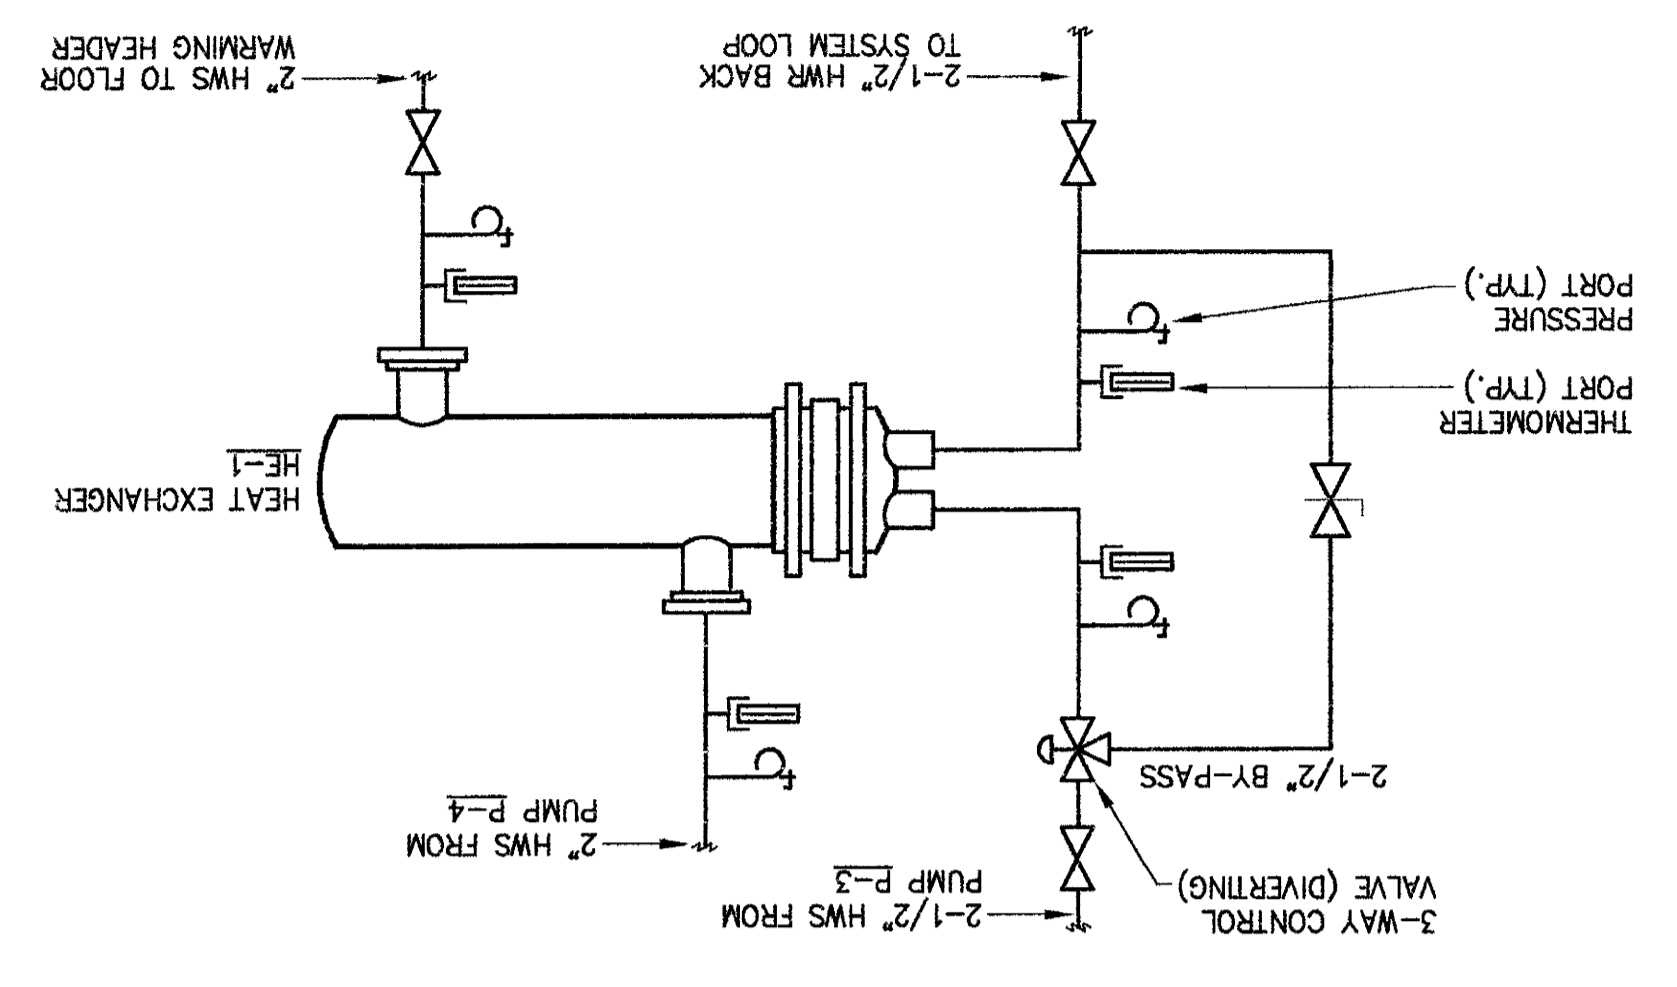

3 RETURN HEADER DETAIL
M-3 NTS

