




1 FLOOR PLAN 'B'
 P-4 1/4"=1'-0" FFE = 1863'

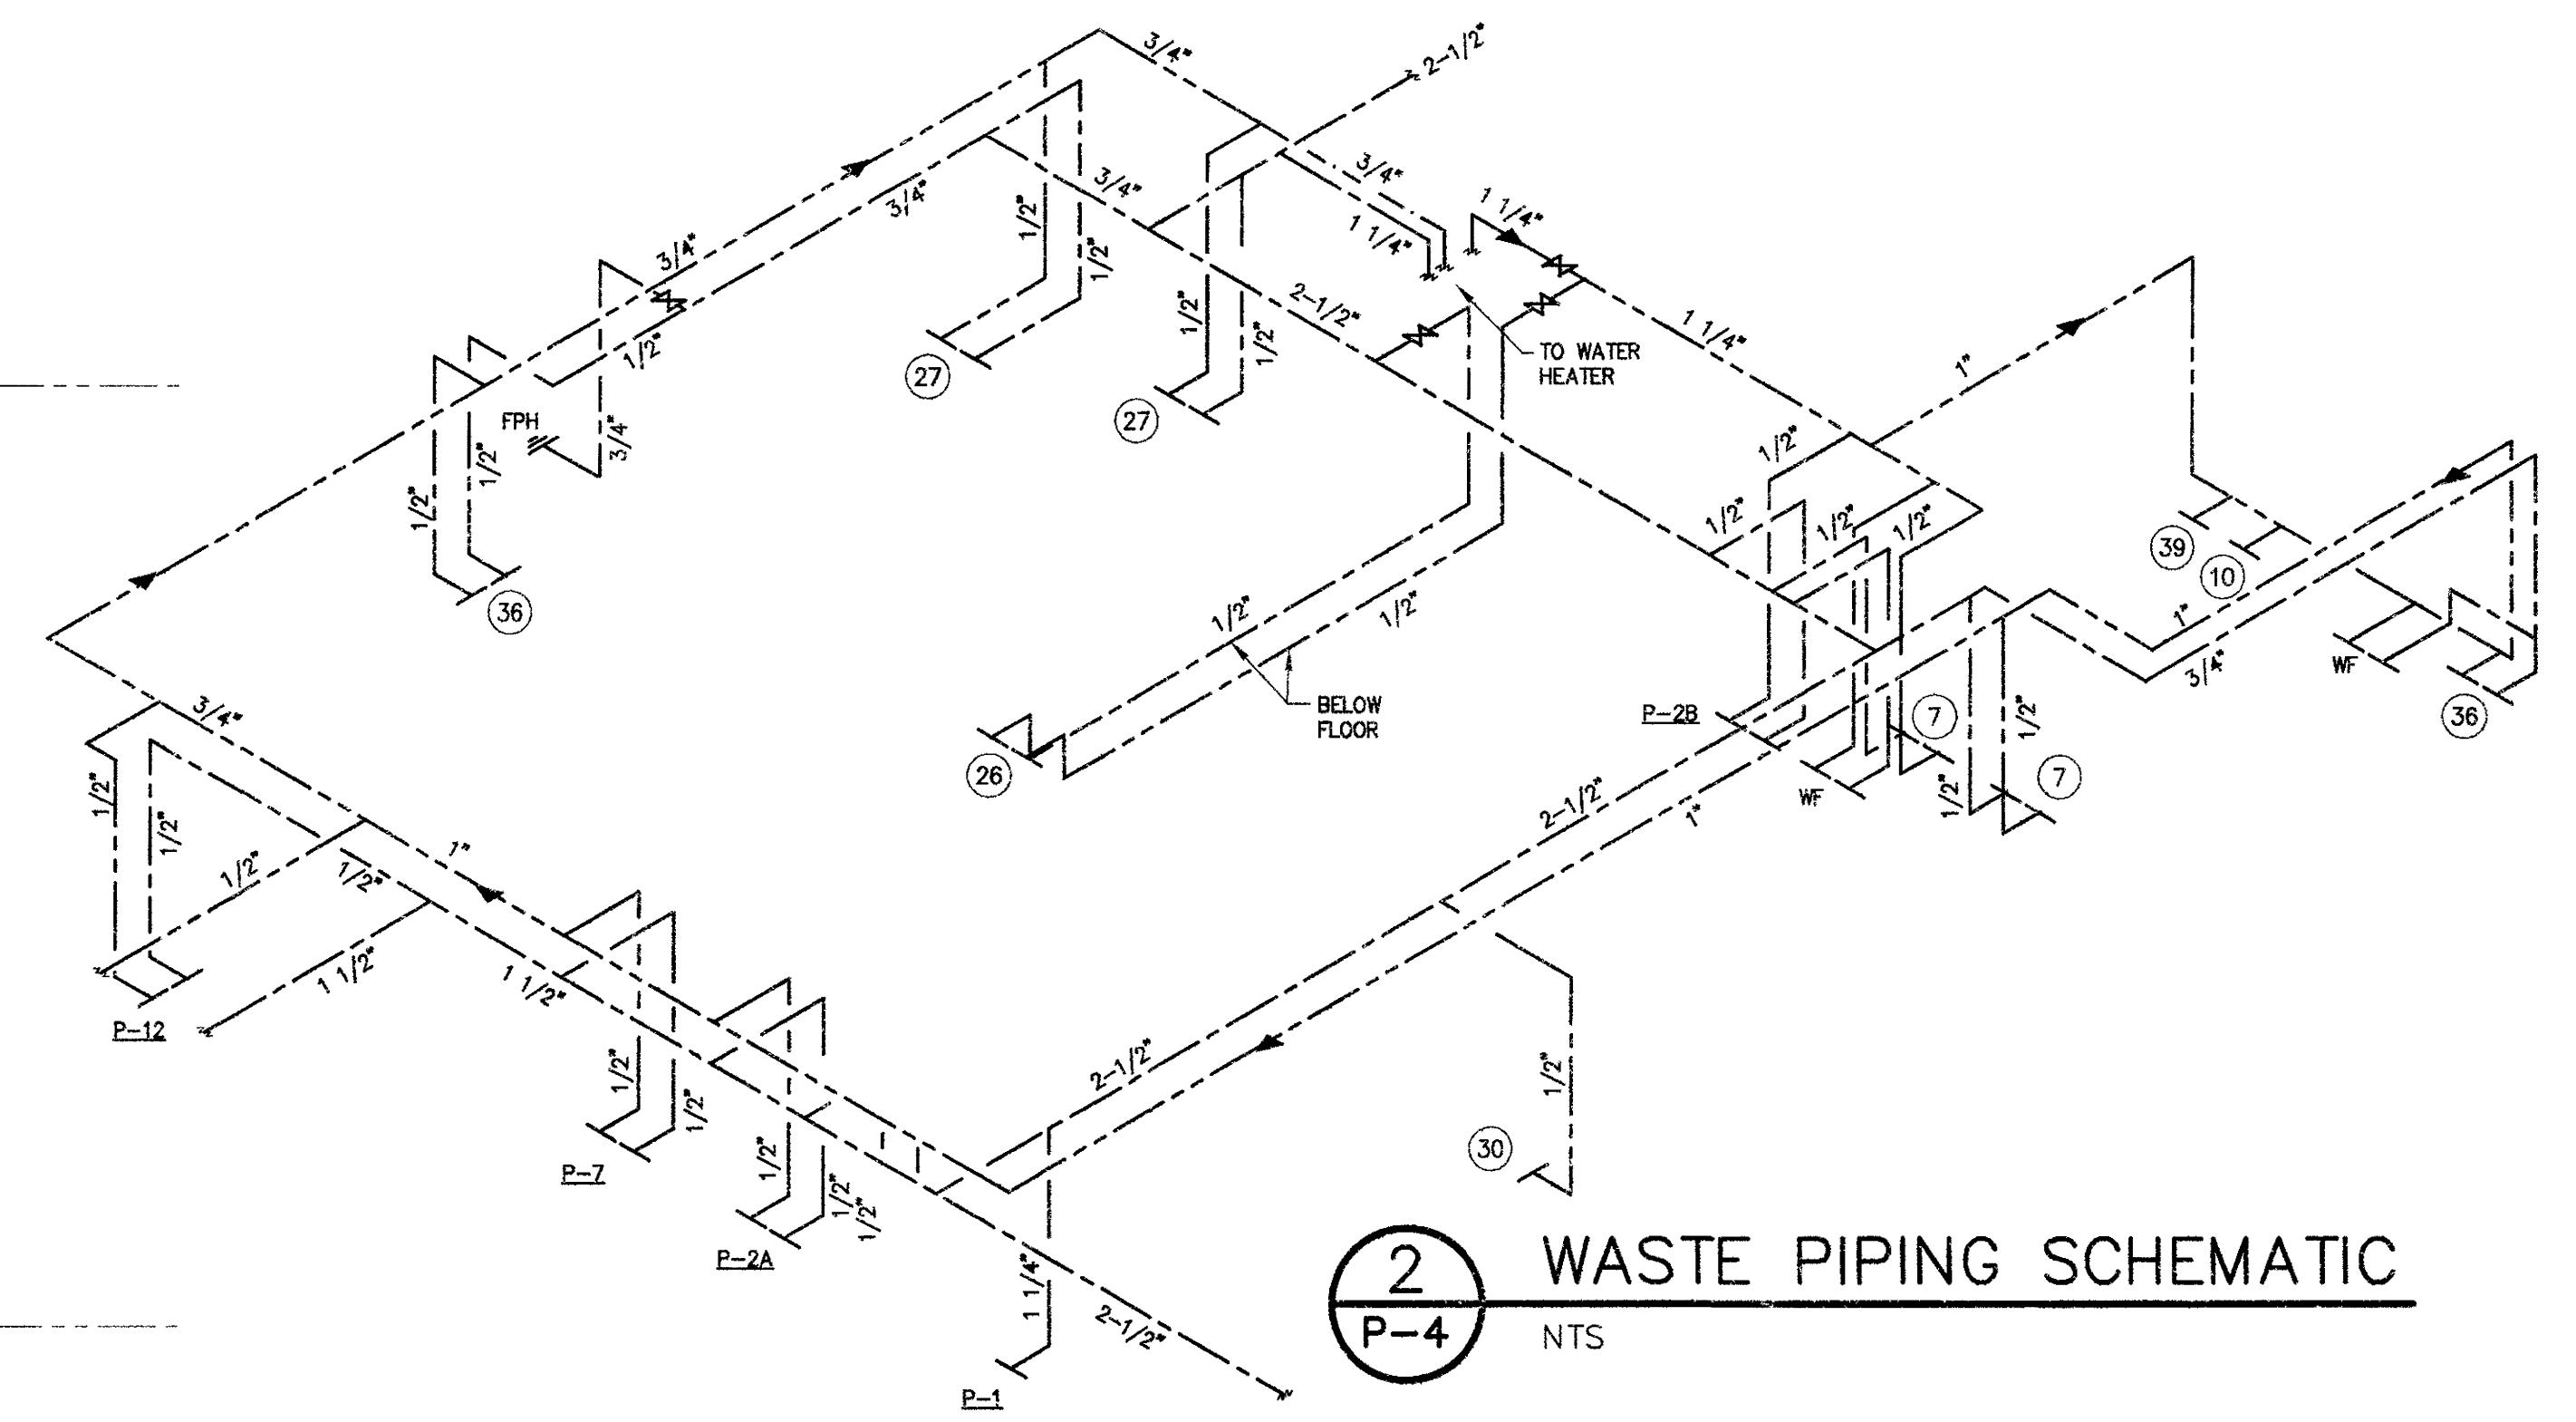

2 WASTE PIPING SCHEMATIC
 P-4 NTS

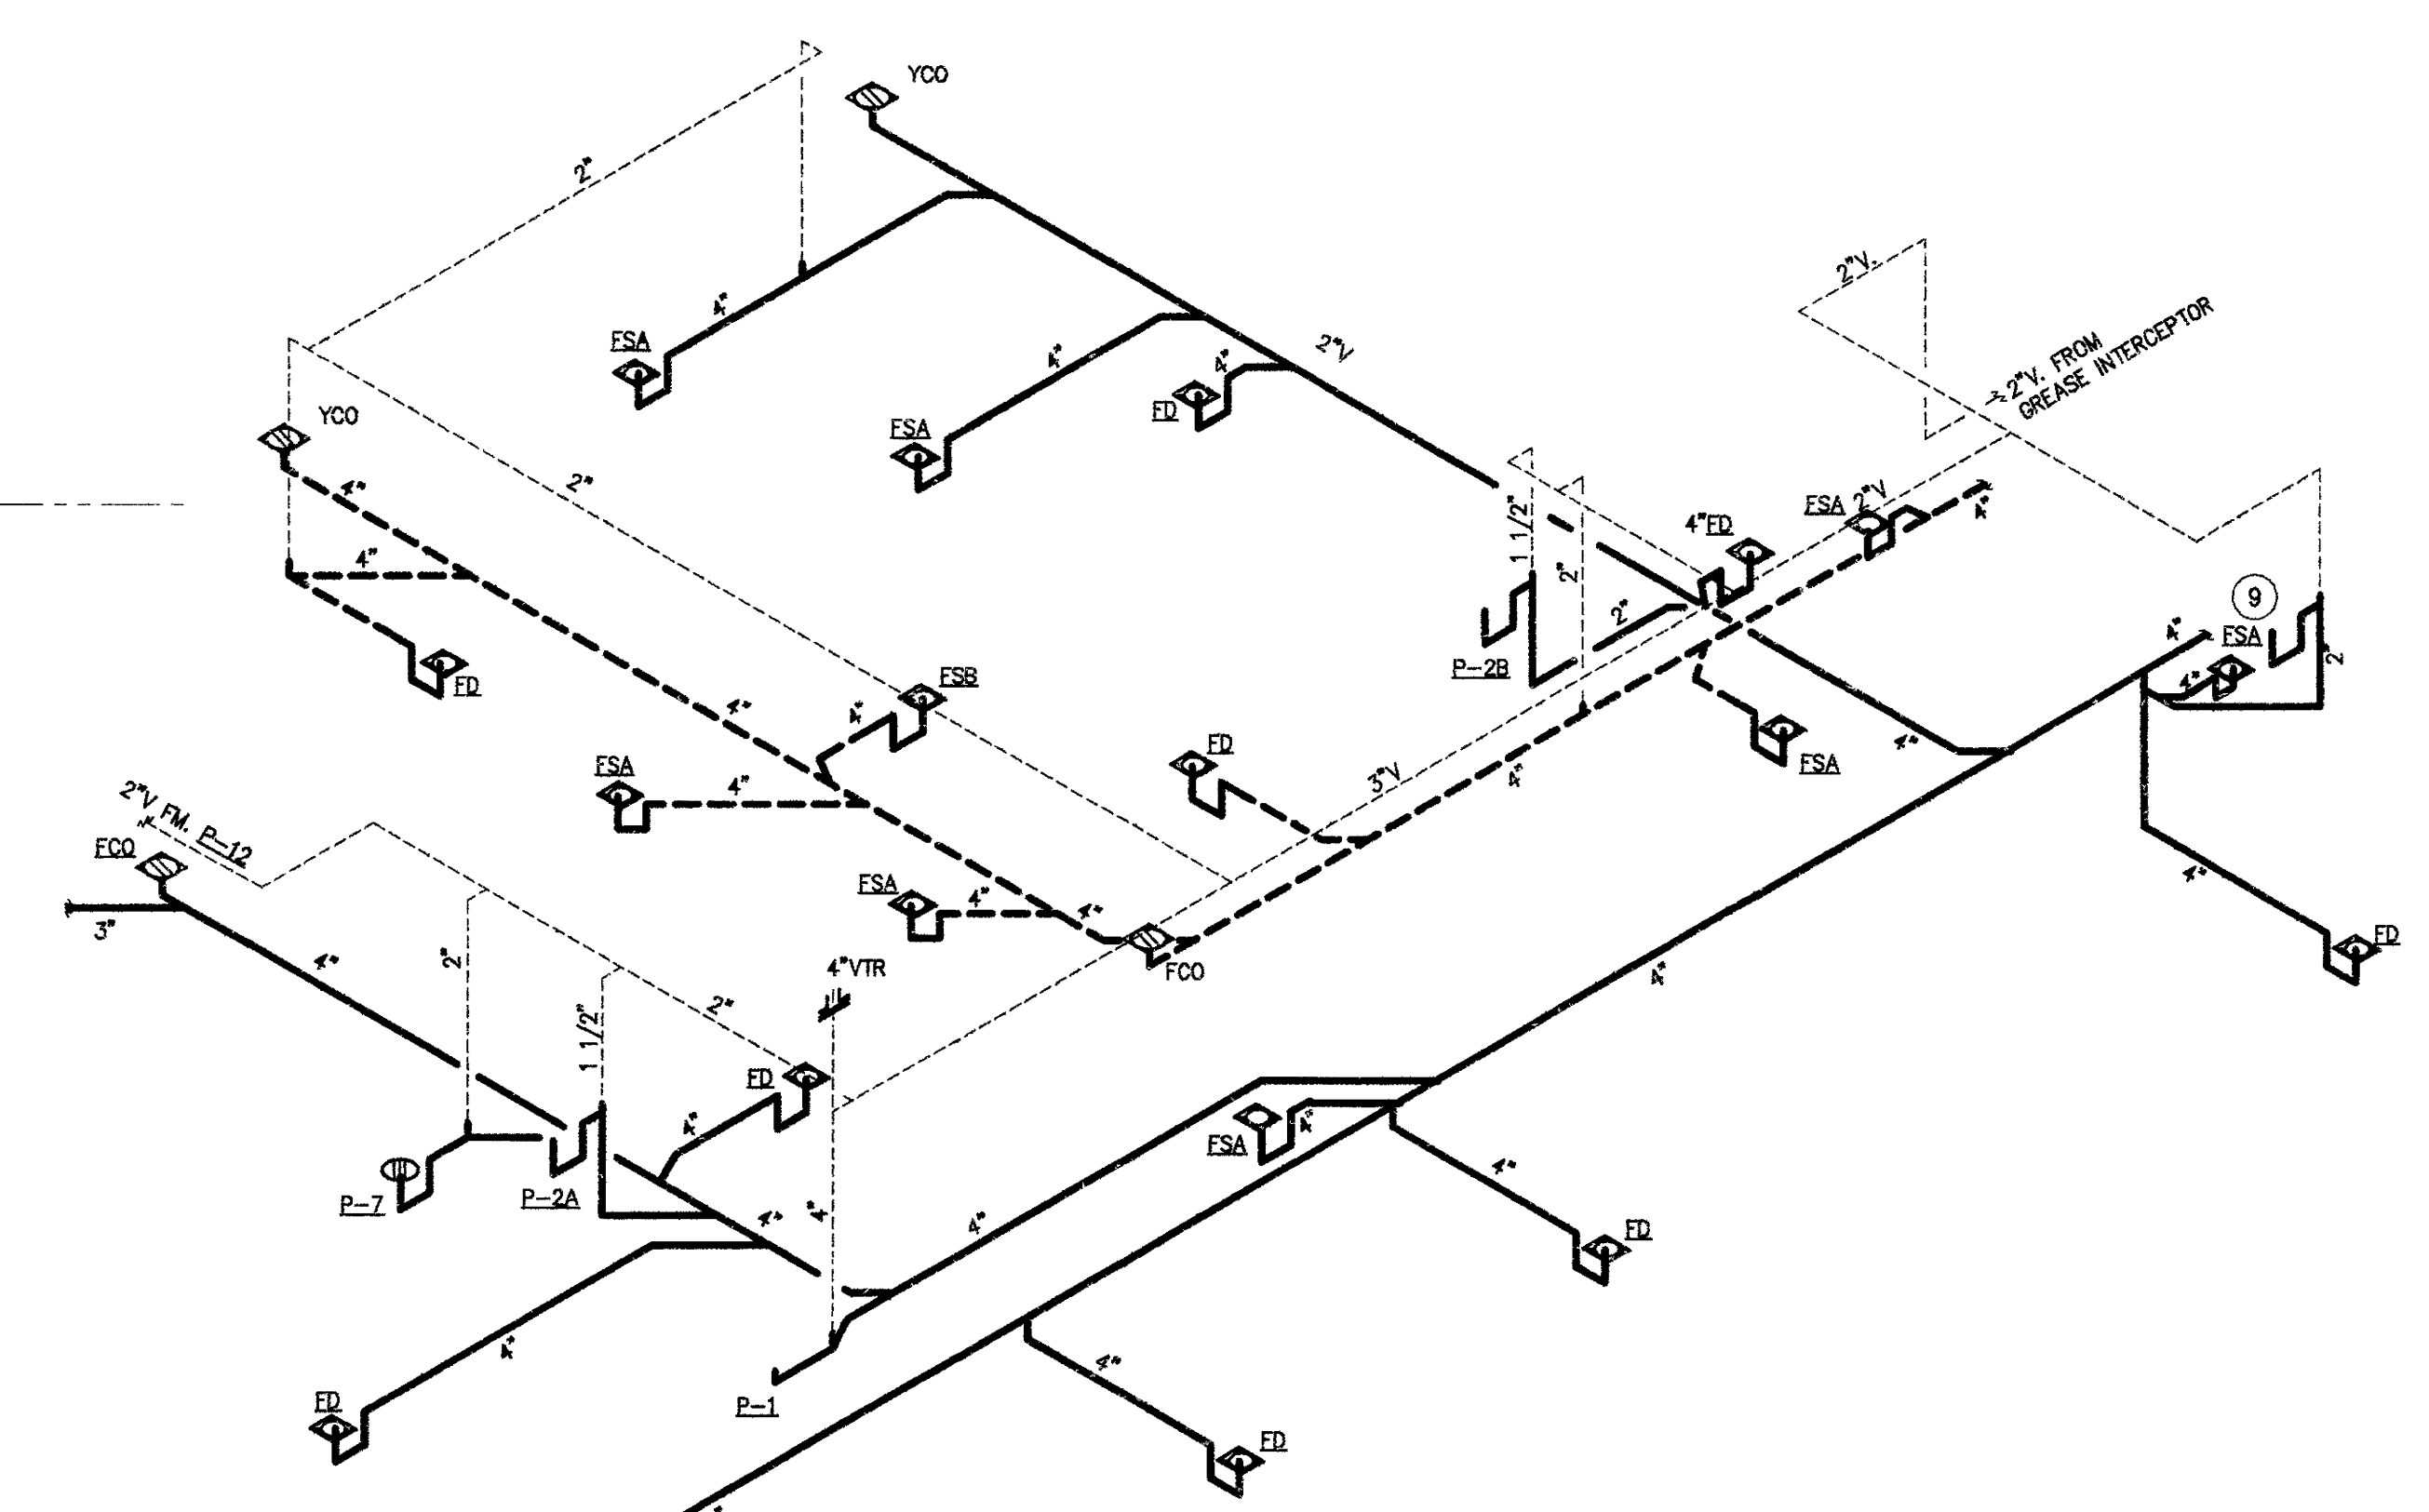


3 WASTE PIPING SCHEMATIC
 P-4 NTS

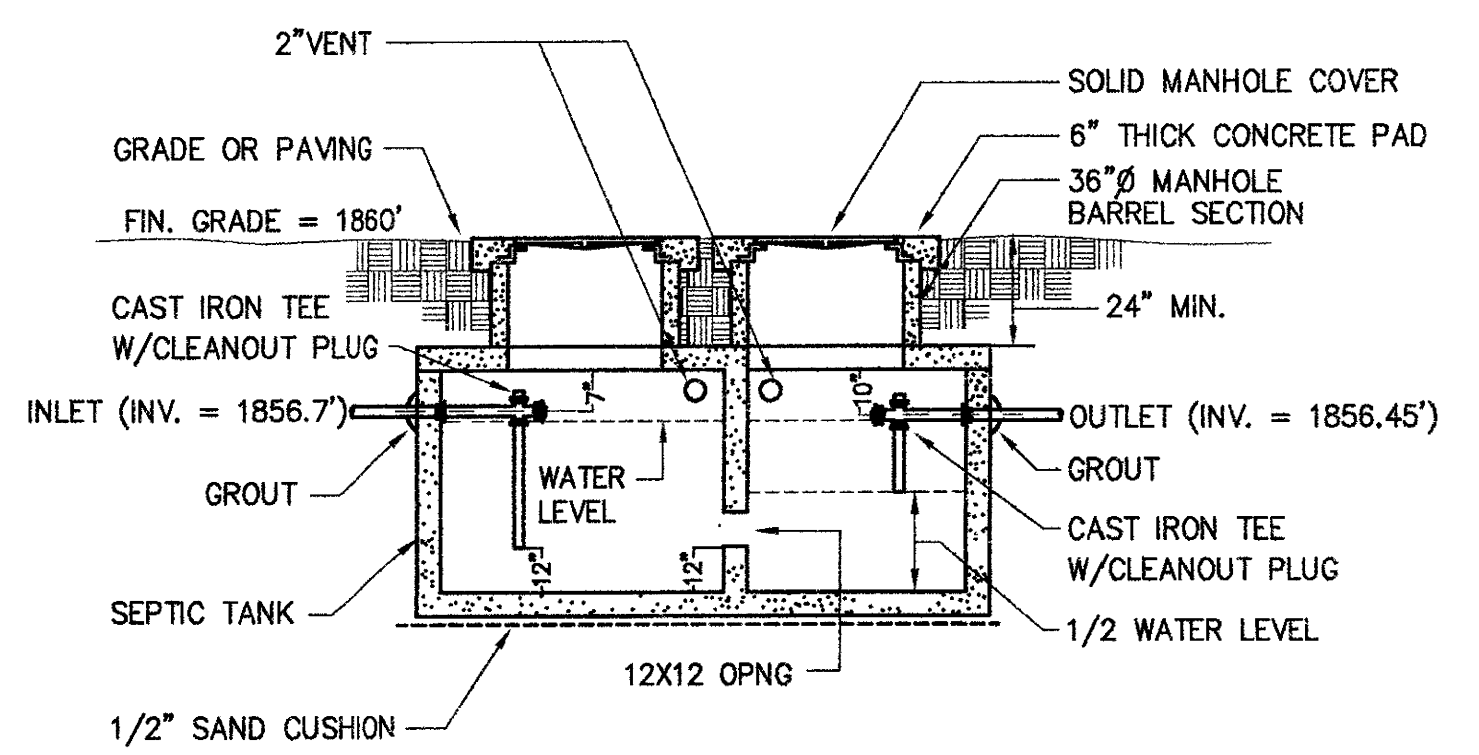

4 GREASE INTERCEPTOR DETAIL
 P-4 NTS (1500 GAL. PRECAST)

KITCHEN EQUIPMENT SCHEDULE								
SYM	NAME	CW	HW	140° HW	WASTE	IW	V	DESCRIPTION
7	THREE COMPARTMENT SINK	YES	-	YES	-	YES	-	BY OTHERS. P.C. TO ROUGH-IN & MAKE FINAL CONNECTIONS.
9	FOODWASTE DISPOSER	-	-	-	YES	-	YES	BY OTHERS. P.C. TO ROUGH-IN & MAKE FINAL CONNECTIONS.
10	DISHWASHER	-	-	YES	-	YES	-	BY OTHERS. P.C. TO ROUGH-IN & MAKE FINAL CONNECTIONS.
26	TILTING KETTLE	YES	-	YES	-	YES	-	BY OTHERS. P.C. TO ROUGH-IN & MAKE FINAL CONNECTIONS.
27	ONE COMPARTMENT SINK	YES	-	YES	-	YES	-	BY OTHERS. P.C. TO ROUGH-IN & MAKE FINAL CONNECTIONS.
30	ICEMAKER	YES	-	-	-	YES	-	BY OTHERS. P.C. TO ROUGH-IN & MAKE FINAL CONNECTIONS.
36	HOSE & SPRAY UNIT	YES	-	YES	-	YES	-	BY OTHERS. P.C. TO ROUGH-IN & MAKE FINAL CONNECTIONS.
39	BOOSTER HEATER	-	-	YES	-	YES	-	BY OTHERS. P.C. TO ROUGH-IN & MAKE FINAL CONNECTIONS.
40	BOOSTER HEATER	-	-	YES	-	YES	-	BY OTHERS. P.C. TO ROUGH-IN & MAKE FINAL CONNECTIONS.

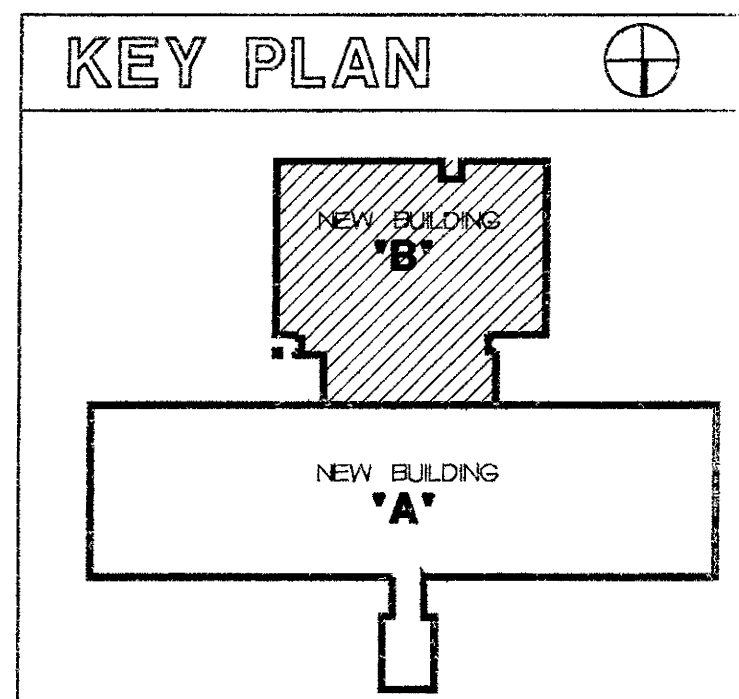


ARCHITECTURE
 PROFESSIONAL ASSOCIATION
 277-5555

ASSOCIATION
 OF PROFESSIONAL ENGINEERS
 277-5555

REGISTERED PROFESSIONAL ENGINEER
 IN THE STATE OF NORTH CAROLINA
 277-5555

McKNIGHT • SMITH
 WARD • GRIFFIN
 ENGINEERS, INCORPORATED
 PO Box 240826 • 4223 South Boulevard
 Charlotte, NC 28224

ANDREWS
 MIDDLE SCHOOL
 CHEROKEE COUNTY, N.C.

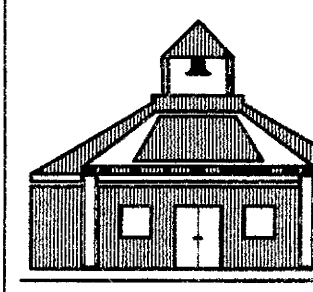

CHEROKEE COUNTY SCHOOLS

SHEET TITLE
 KITCHEN PLAN & SCHEMATIC

DRAWN BY CDT APPROVED LMW
 JOB NO. AMS-971C
 APPROVAL DATE 4/21/9
 BID ISSUE DATE 4/28/9
 REVISIONS ?/?/9

SHEET P-4
 OF 5